



storm drain has to be extended


storm and foul drainage layout scale 1 : 500

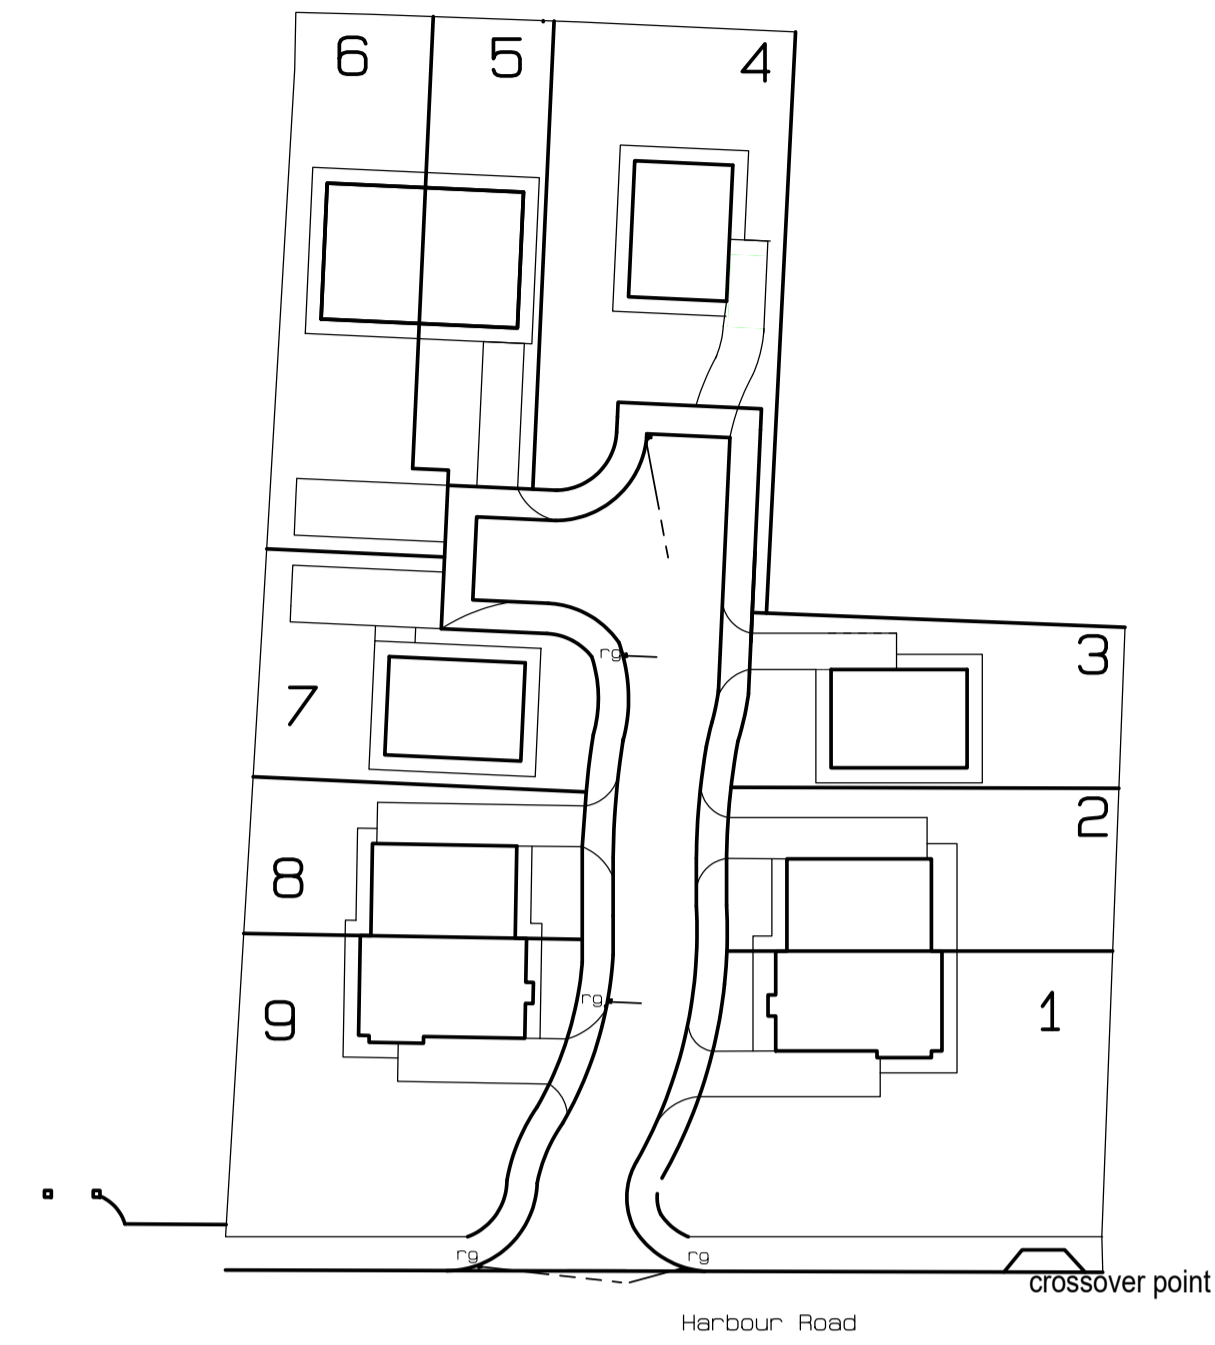

drainage gullies and tails only scale 1 : 500

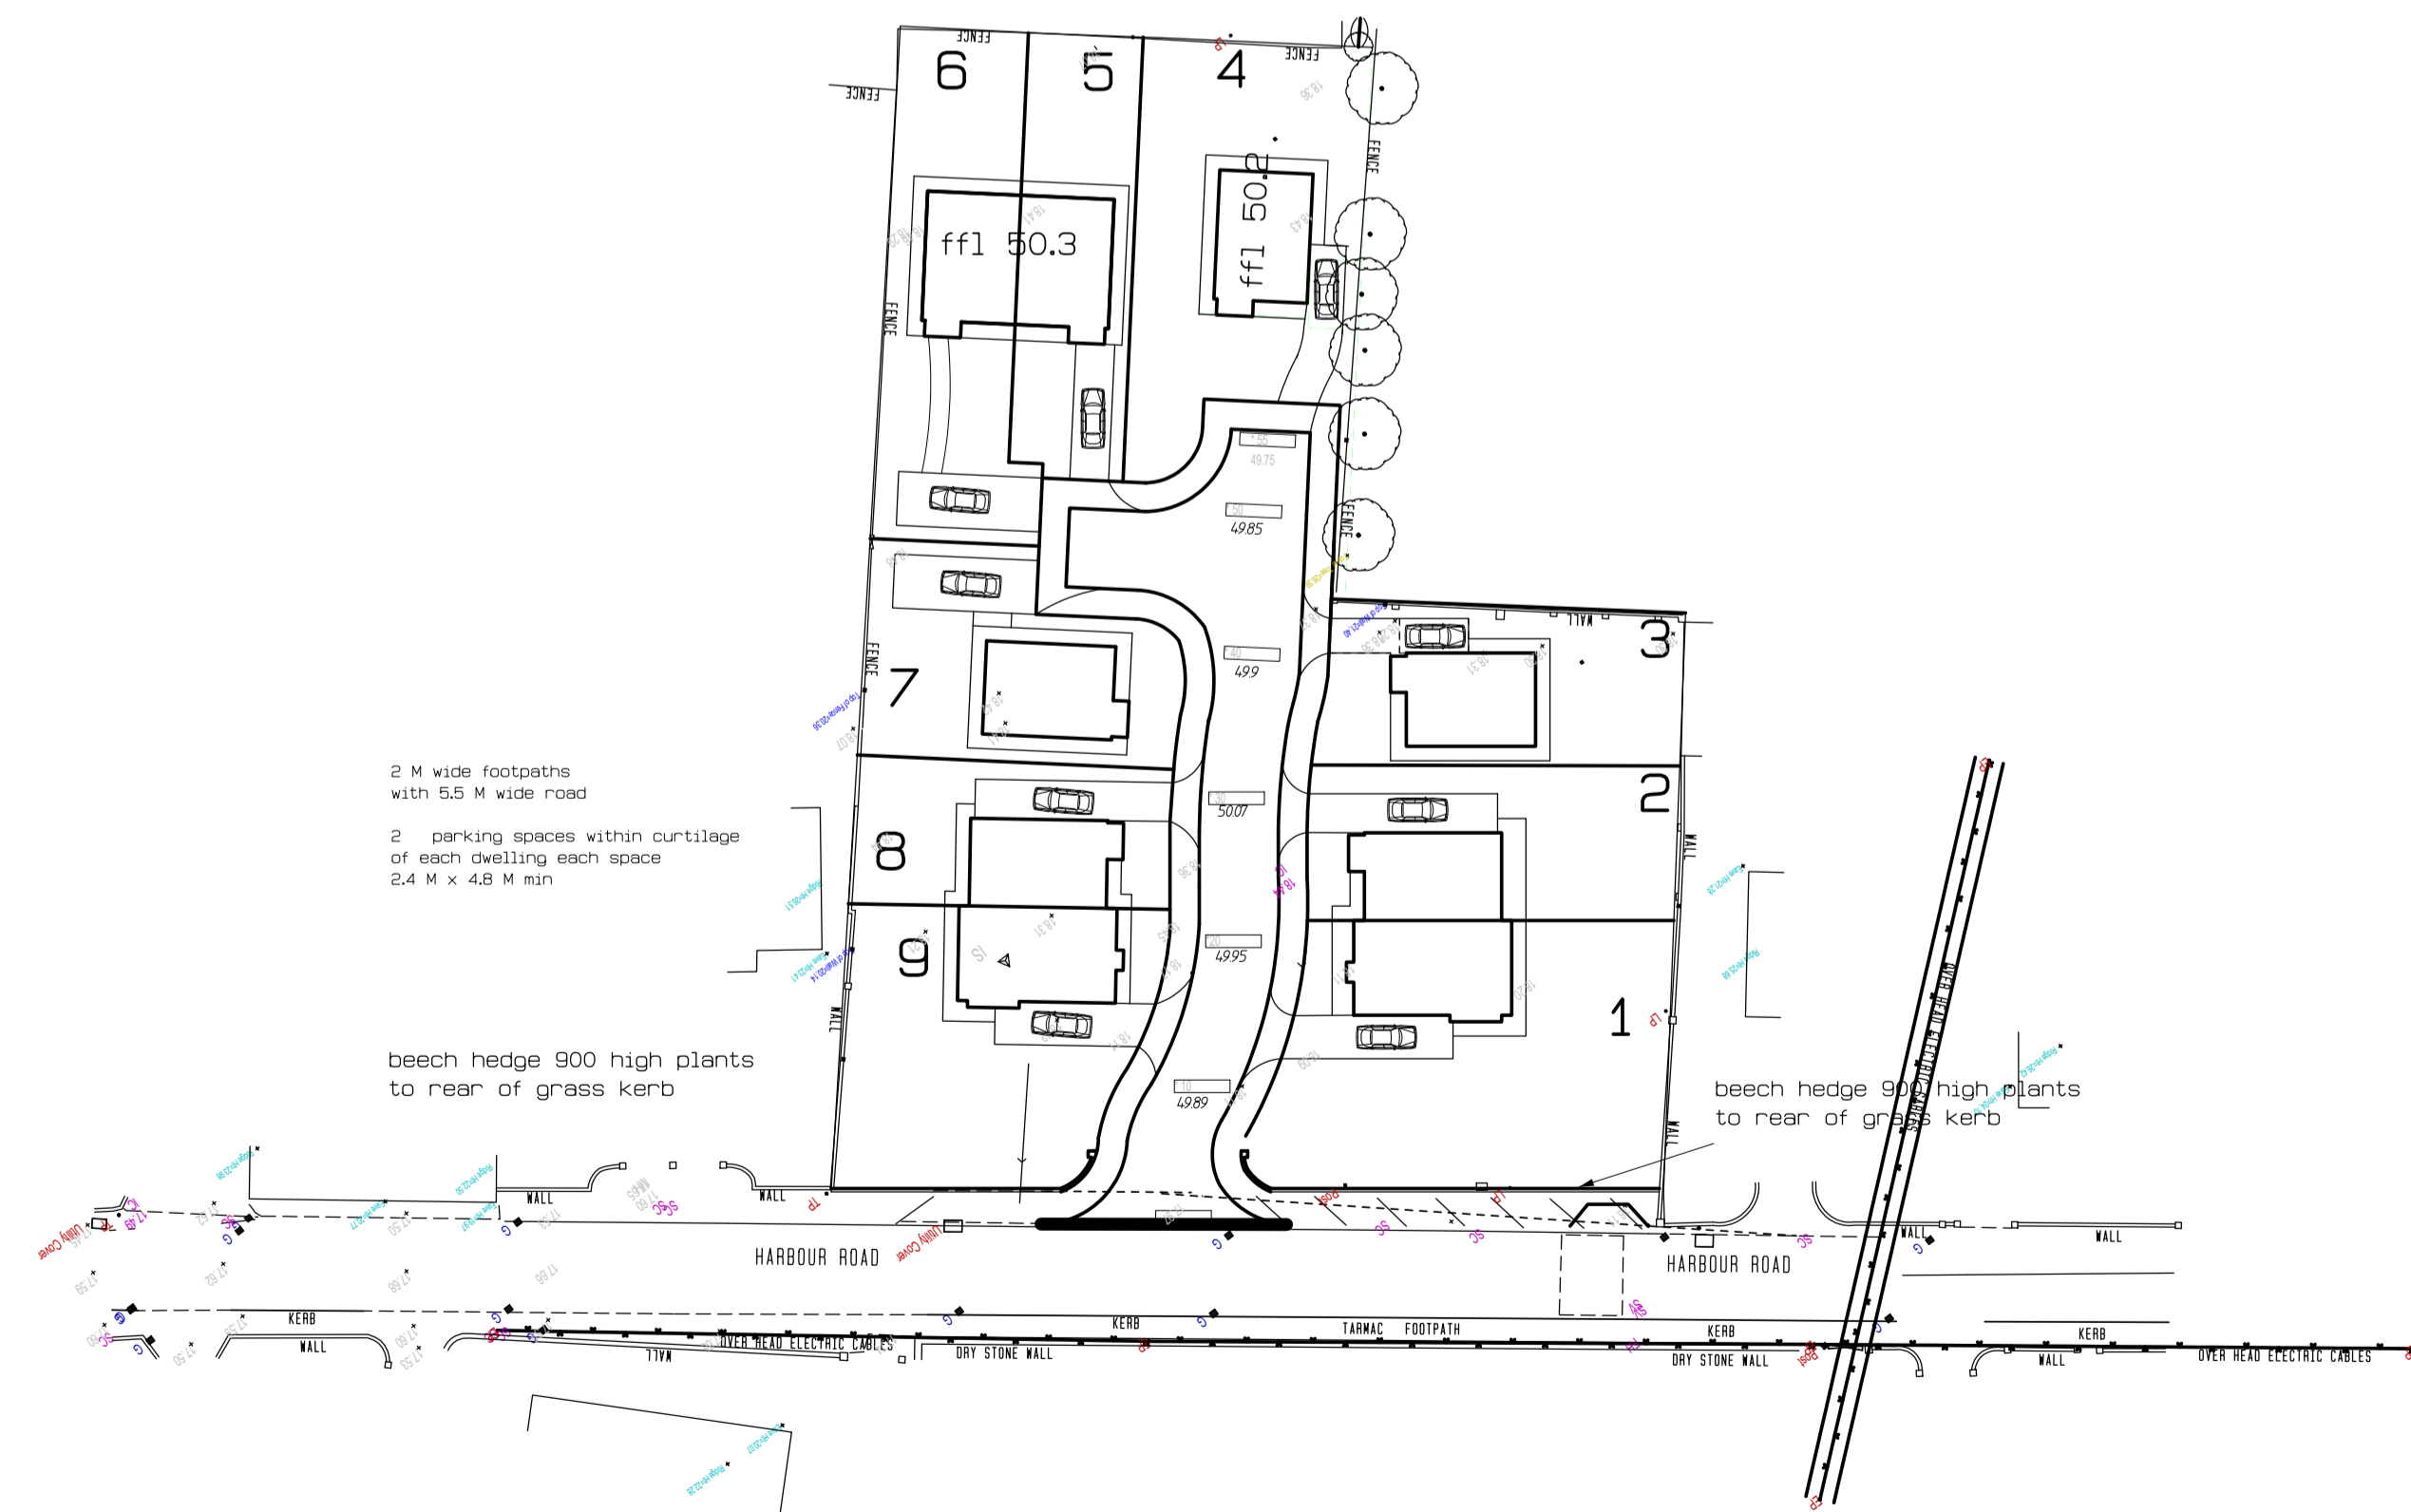


site plan scale 1 : 500

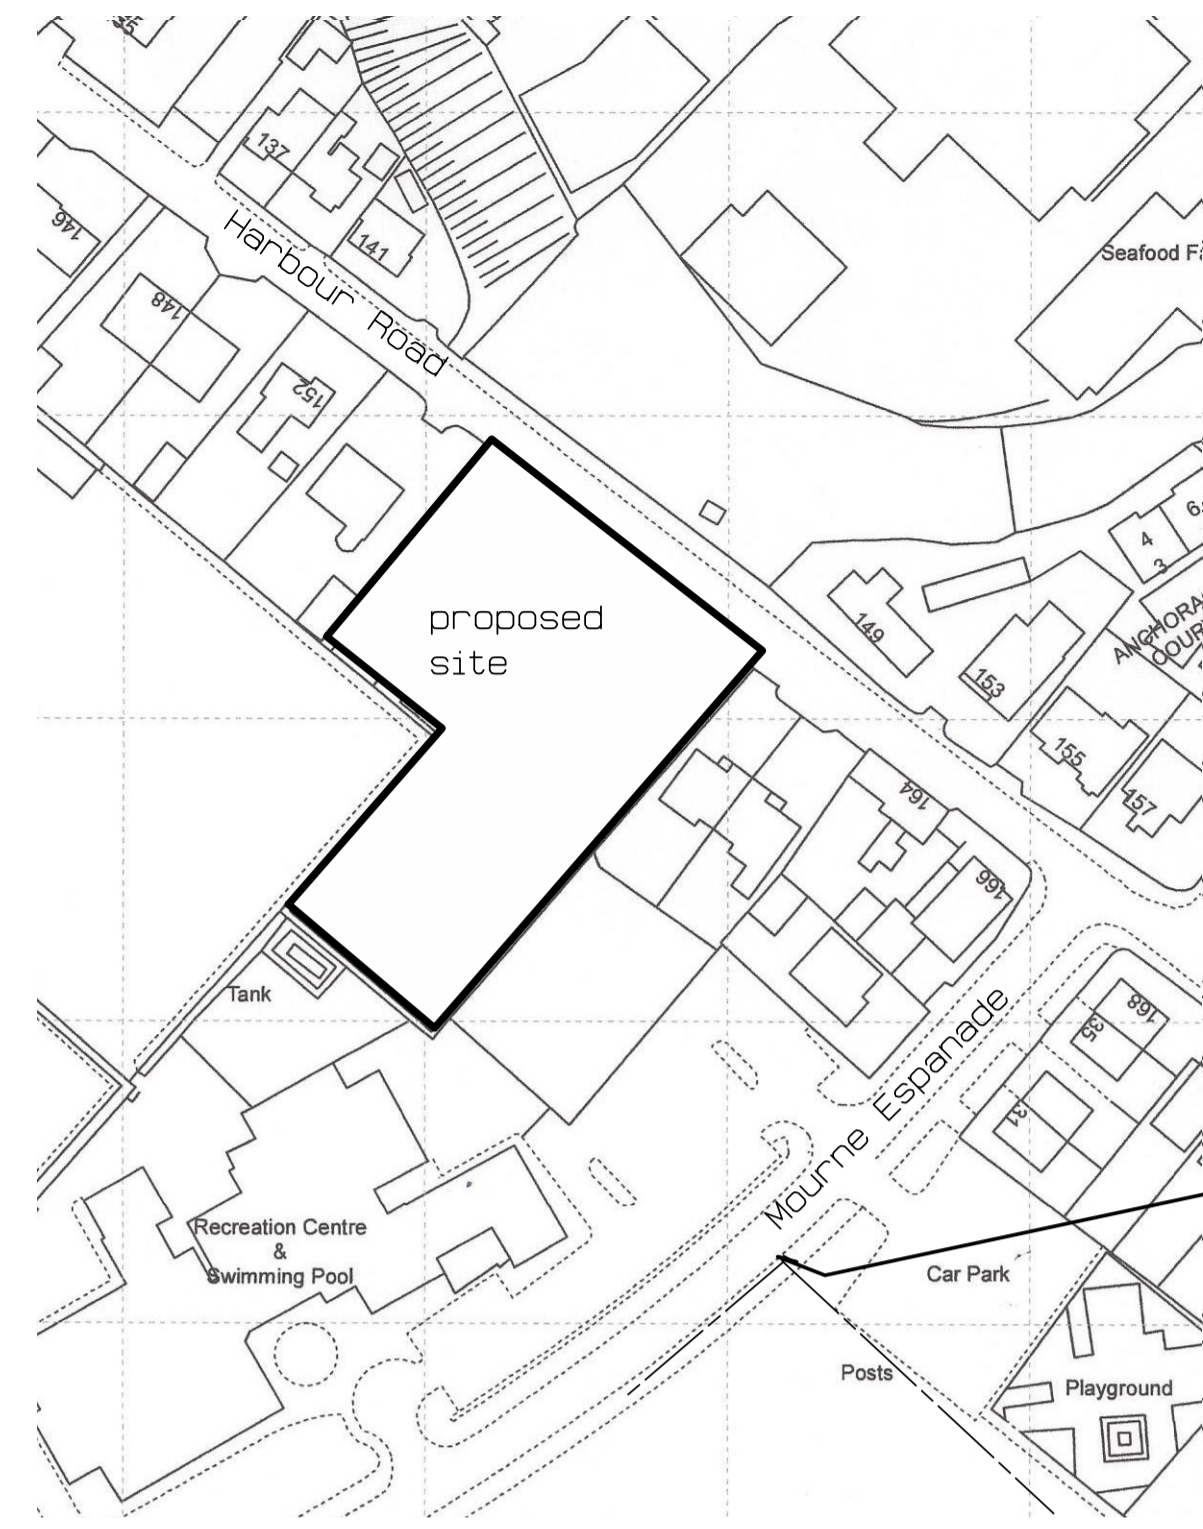


location plan O.S. Plan 284-8NE1 scale 1 :1250

house No.	FFL	FGL on path	amenity area
1	50.35	50.2	108
2	50.35	50.2	132
3	50.2	50.05	108
4	50.3	50.15	70
5	50.3	50.15	75
6	50.3	50.15	113
7	50.3	50.15	90
8	50.2	50.05	143
9	50.2	50.05	102


nearest storm drain

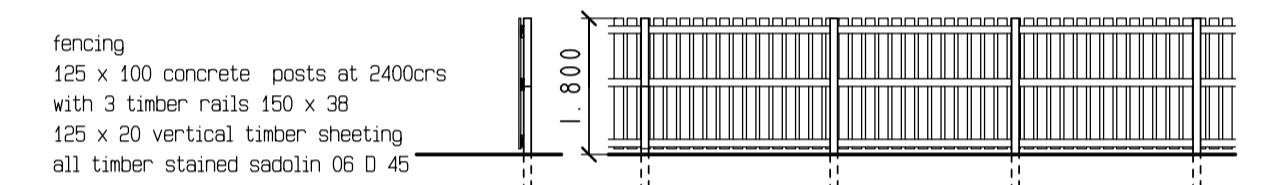

fencing type A scale 1 : 100

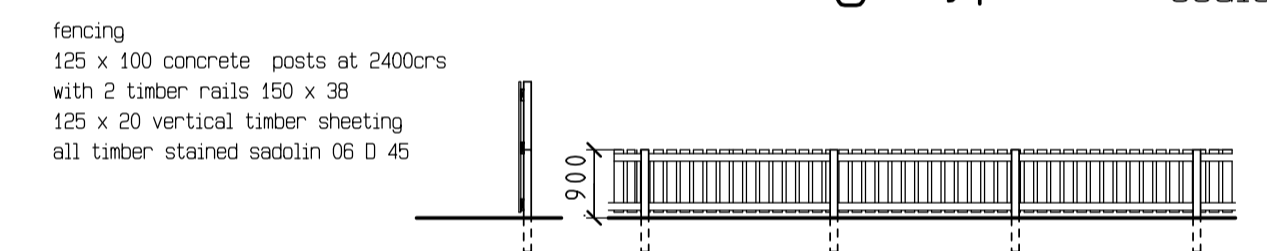

fencing type B scale 1 : 100

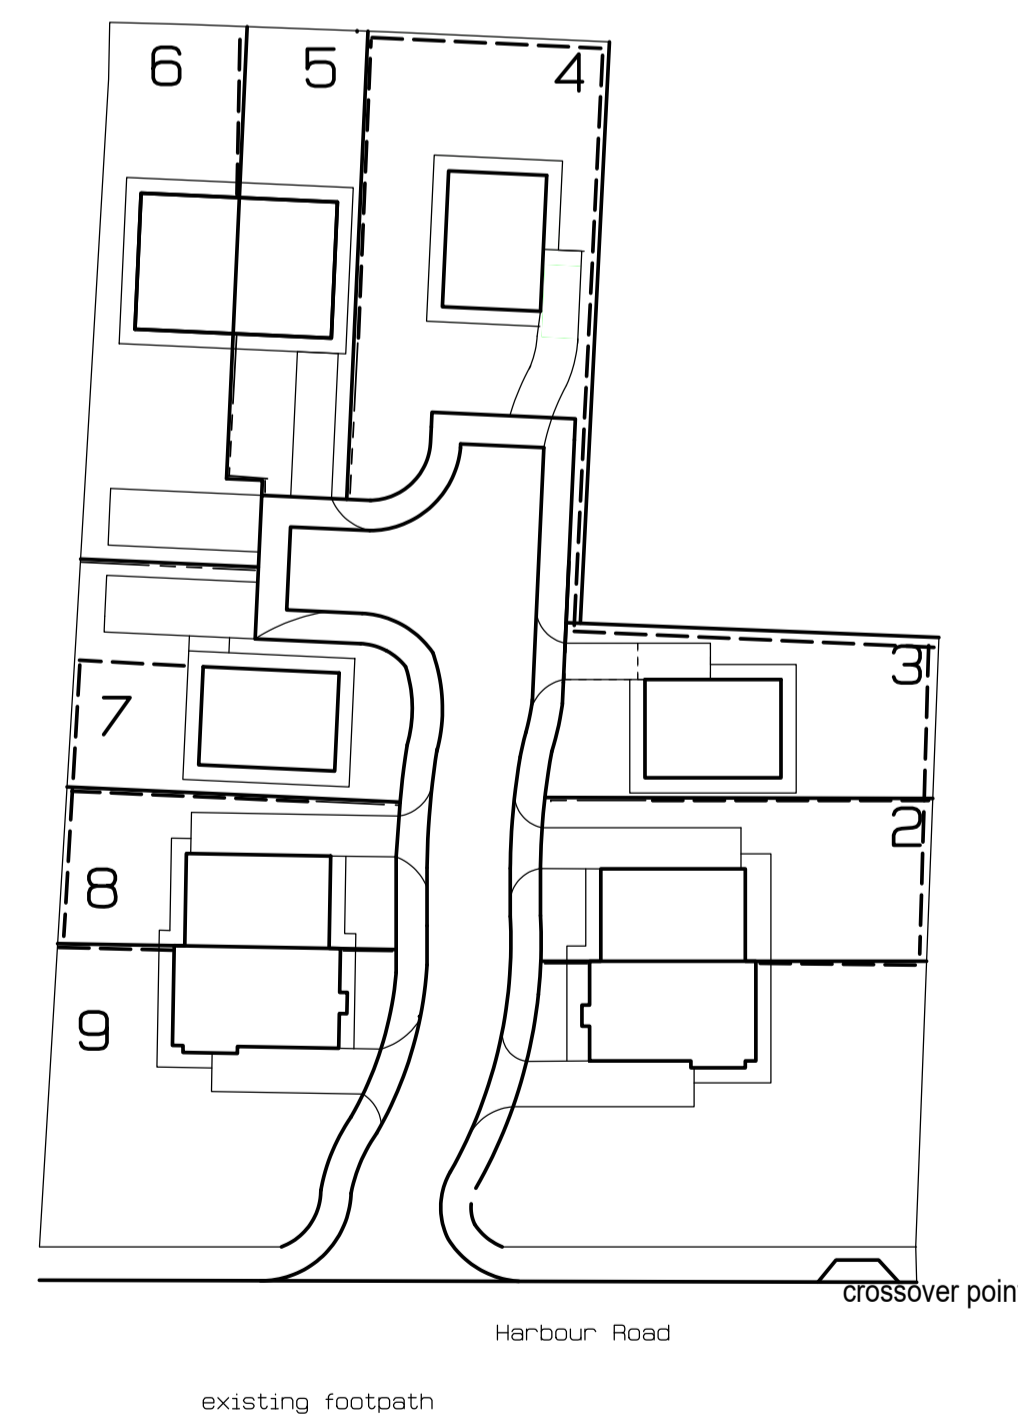

fencing scale 1 : 500

project title Proposed housing development at 158 Harbour Road, Kilkeel, for, McKinley Contracts Limited.	
drawing title location plan site plan ,drainage, planting and fencig layout	
scales as noted	date 14-02-2018
drawing no. 2830sp	revision letter
COLE PARTNERSHIP architecture & project management	
12a Duke Street, Warrenpoint . Co Down BT 34 JY Tel: 028417 53679 Fax: 028417 52030 e-mail: cp.arch@tiscali.co.uk	